



FIRST FLOOR PLAN - HEATING
SCALE: 1/4" = 1'-0"

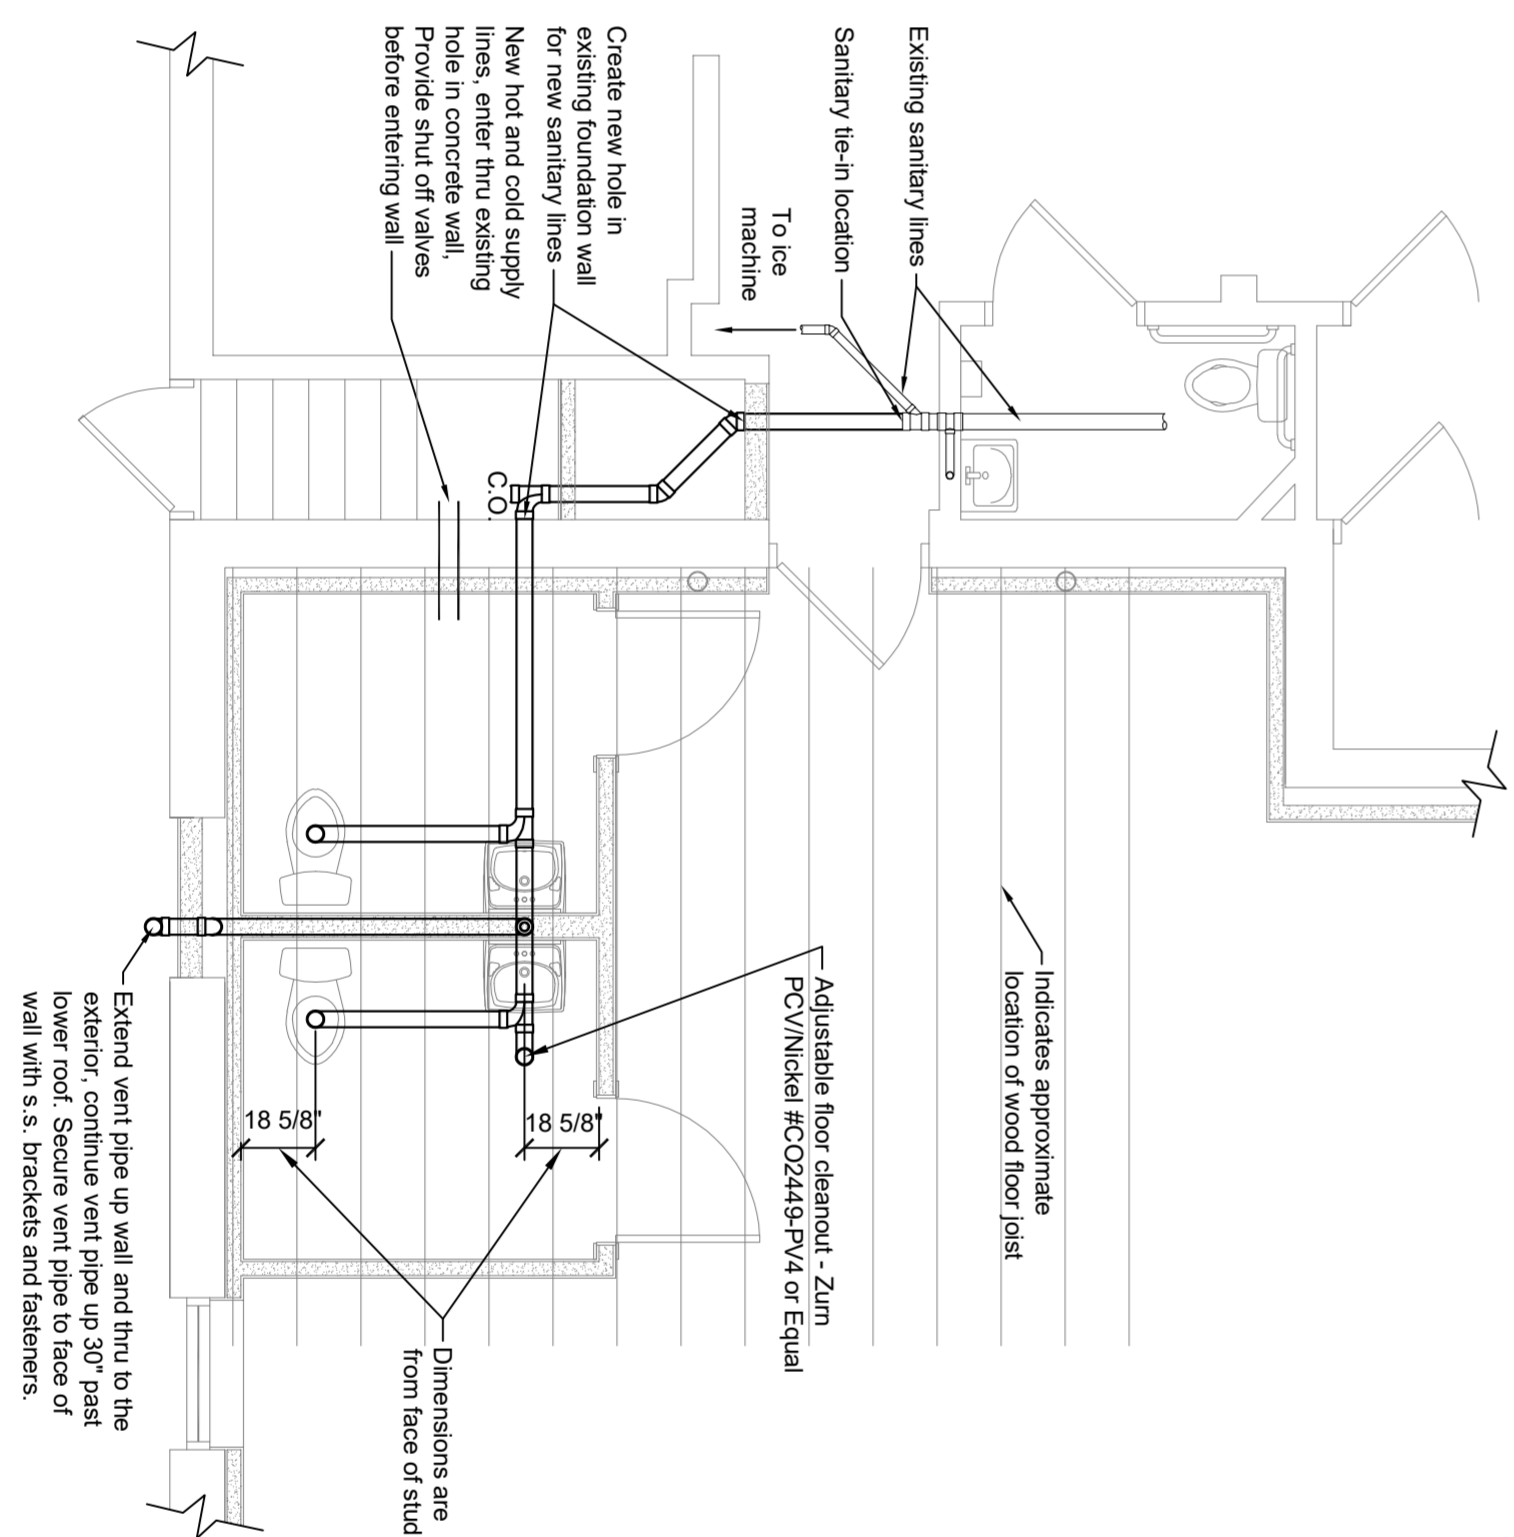


PARTIAL PLUMBING PLAN
SCALE: 1/4" = 1'-0"

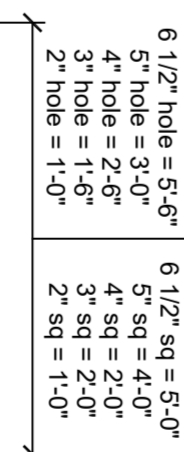

ALLOWABLE HOLES
SCALE: NOT TO SCALE

PLUMBING GENERAL NOTES:

- Plumbing Code 2015 of New York State
- New sanitary line match existing size at tie-in location.
- Sanitary line to be schedule 40 pipe and slope 1/4" per ft.
- PVC to be schedule 40 pipe and slope 1/4" per ft.
- Provide and install new 1/2" copper hot and cold water supply lines to new sinks in women's and men's Restrooms.
- Provide and install new 1/2" copper cold water supply line to new toilets in women's and men's Restroom.
- Supply lines shall be supported 5'-0" o.c. and at all changes of direction.
- Copper piping shall be insulated to prevent condensation.

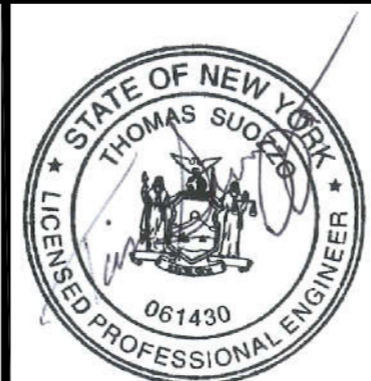

REVISIONS:	
NO.	DATE: DESCRIPTION:

ANY LICENSEE WHO ALTERS THIS DOCUMENT IS REQUIRED BY LAW TO AFFIX HIS OR HER SEAL AND THE NOTATION "ALTERED BY" BY HIS OR HER SIGNATURE AND SPECIFIC DESCRIPTION OF THE ALTERATIONS.
UNAUTHORIZED ALTERATION OR ADDITION TO THIS DOCUMENT IS A VIOLATION OF SECTION 2209 SUBDIVISION 2 OF THE NEW YORK STATE EDUCATION LAW

PROJECT INFORMATION:	
DATE:	11/09/2018
SCALE:	AS SHOWN
DESIGNED BY:	TS
DRAWN BY:	GF
REVIEWED BY:	TS
PROJECT NO.:	17-054
SHEET:	5 OF 6